
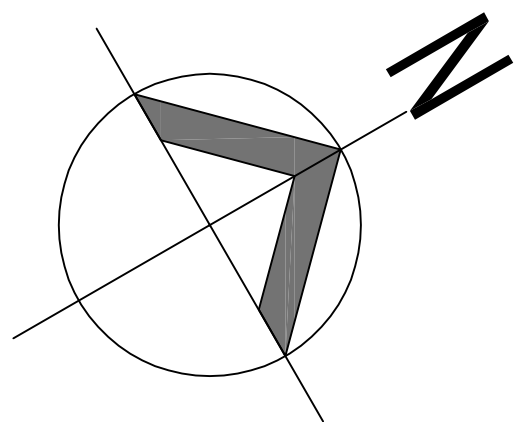



VARIATIONS / WYSYINGS		
DATE DATUM	No Nr	VARIATION WYSYING
.	.	.
SYMBOLS LIST		

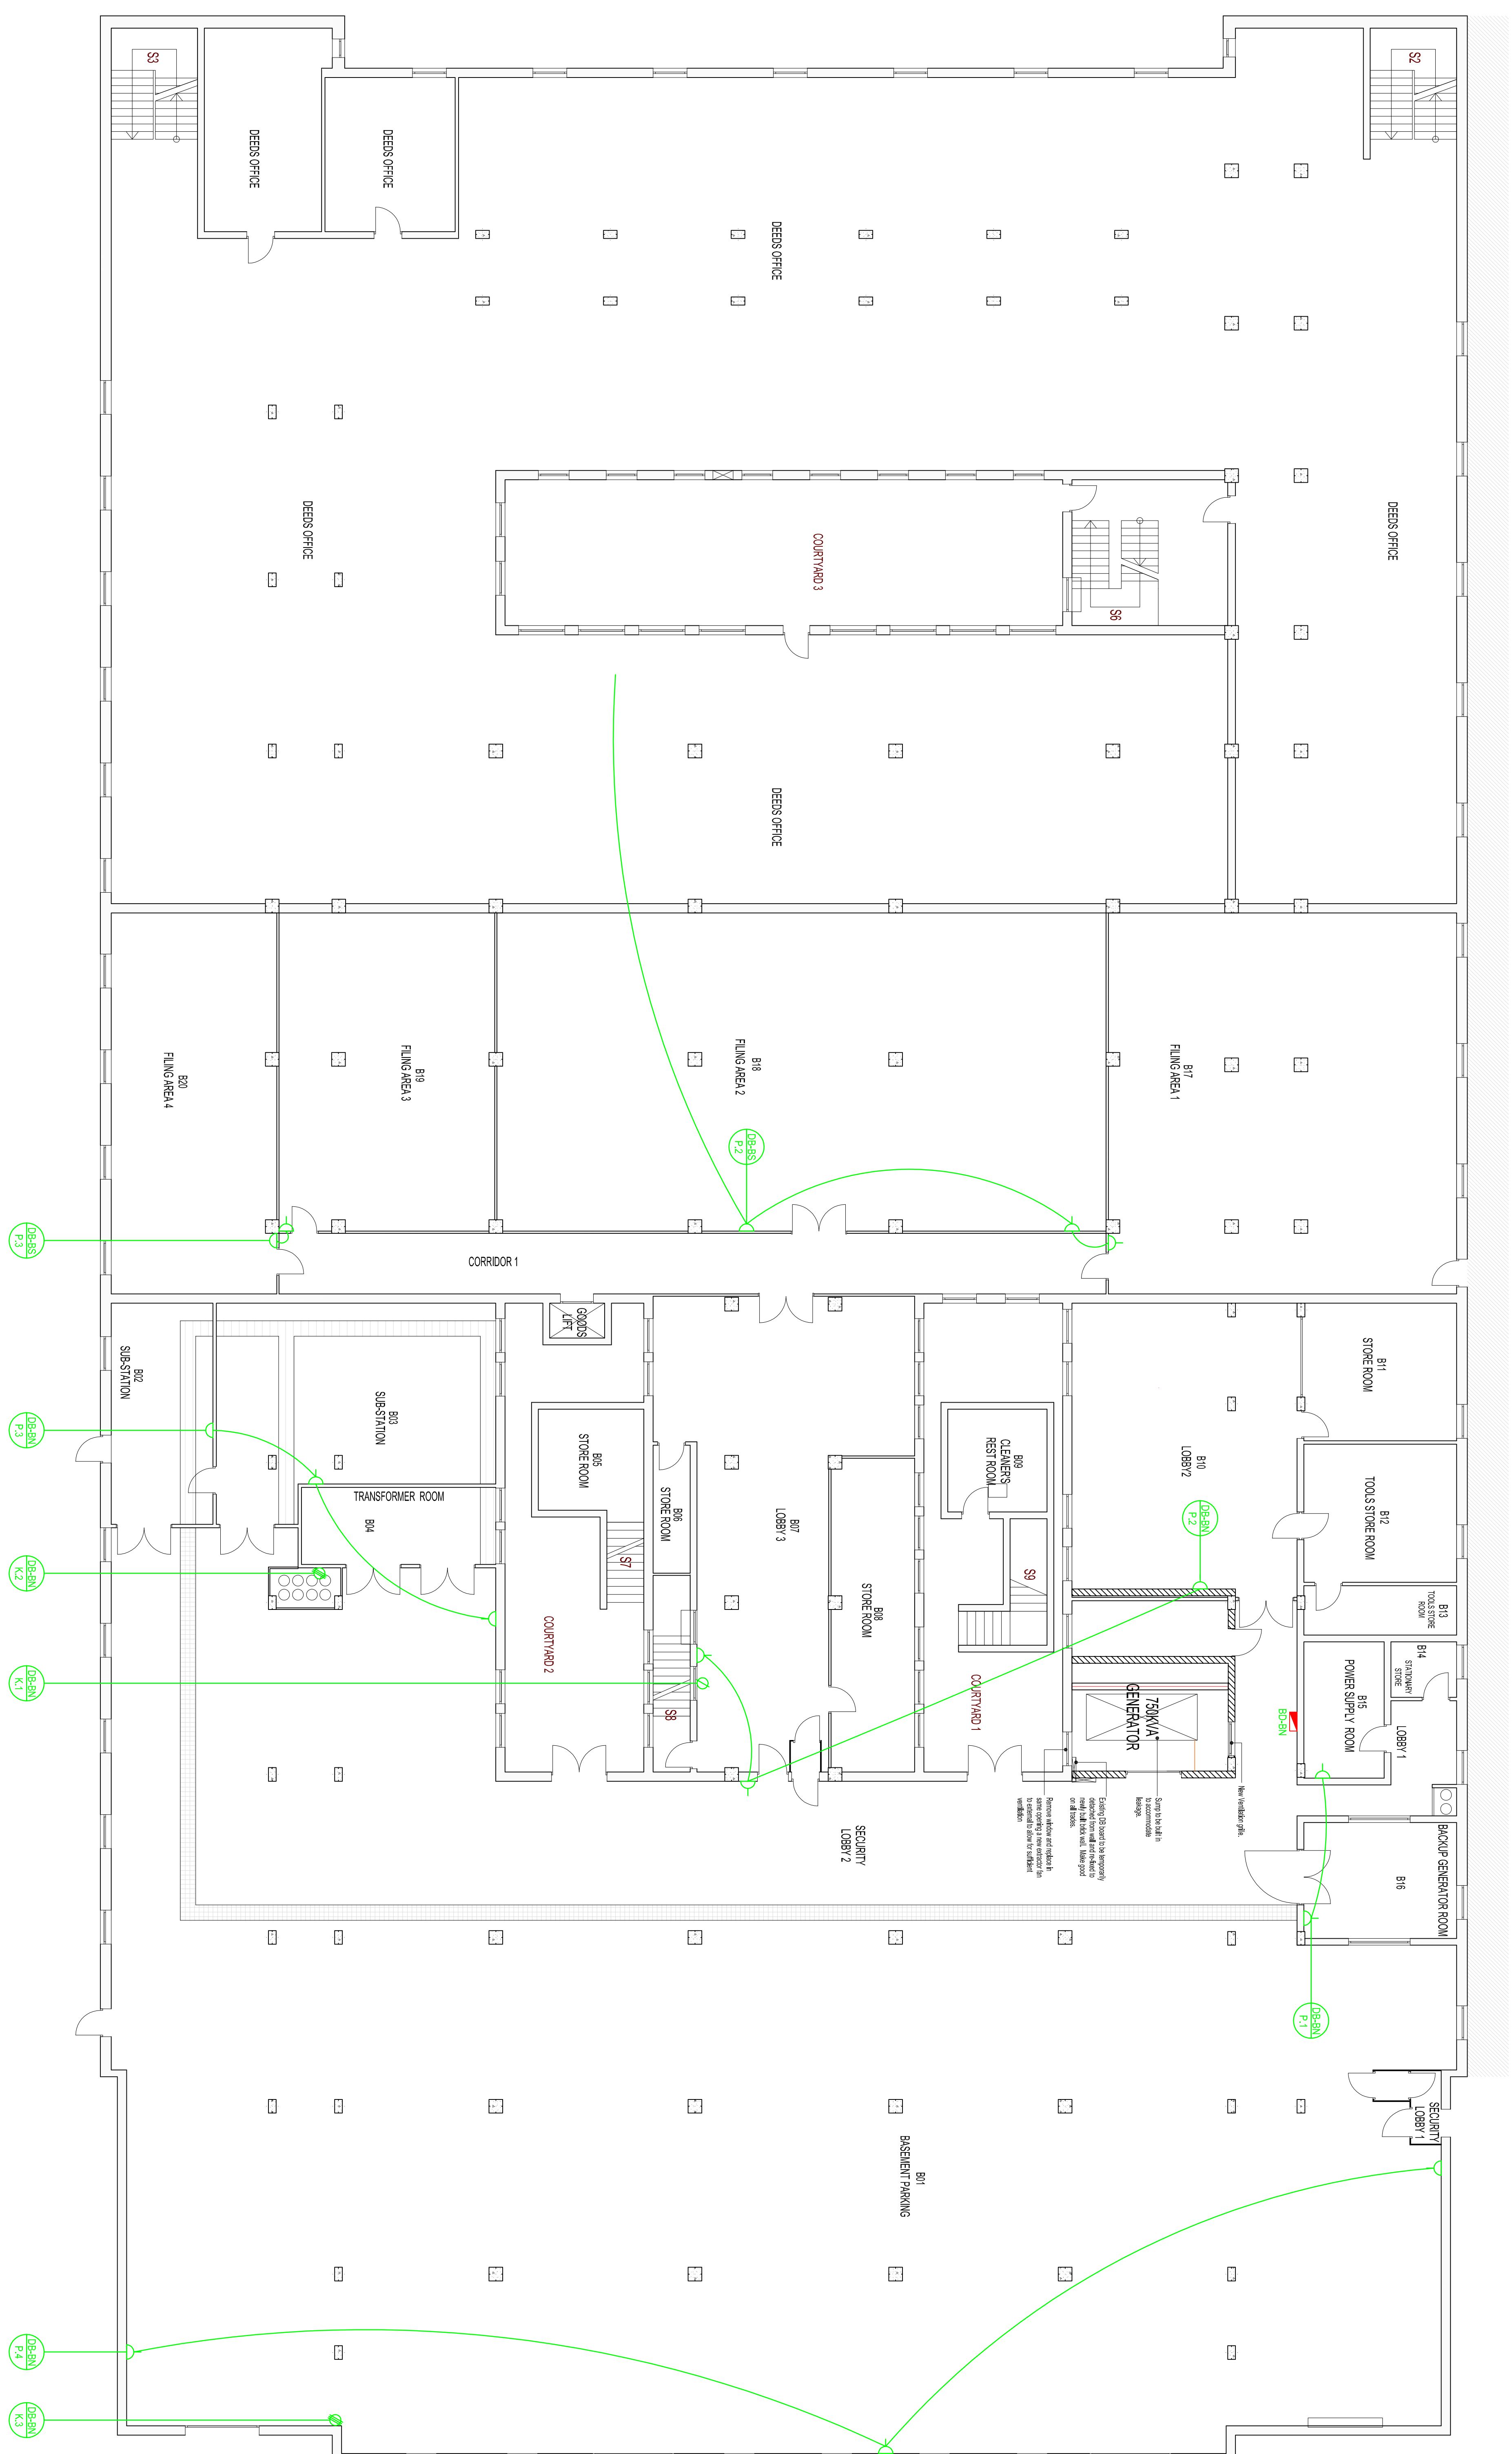

# BASEMENT WORKS PLAN

DESIGNER: ONTWERP:	Q. MOFAT	DATE:
DRAWN: GETEKEN:	A. DU PLOOY	DATE:
CHECKED: NAGESEN:		DATE:
APPROVED: GOEDGEKUR:		DATE:
CLIENT APPROVAL: KLIENT GOEDEKUNING:		DATE:

CLIENT:	CLIENT:
	
PROJECT:	PROJECT:
BLOEMFONTEIN CENTRAL GOVERNMENT BUILDING REFURBISHMENT PROJECT	BLOEMFONTEIN CENTRAL GOVERNMENT BUILDING REFURBISHMENT PROJECT
DRAW DESCRIPTION: <b>ELECTRICAL INSTALLATION</b> TECHNISCHE SKOONINGS	DRAW DESCRIPTION: <b>ELECTRICAL INSTALLATION</b> TECHNISCHE SKOONINGS
BASEMENT SMALL POWER LAYOUT	BASEMENT SMALL POWER LAYOUT

SCALE:	DATE:
NOT TO SCALE	FEBRUARY 2014
DRAWING No:	REVISION:
B03.BFN.000091/E/03	0
DEPT. DRAWING No:	