
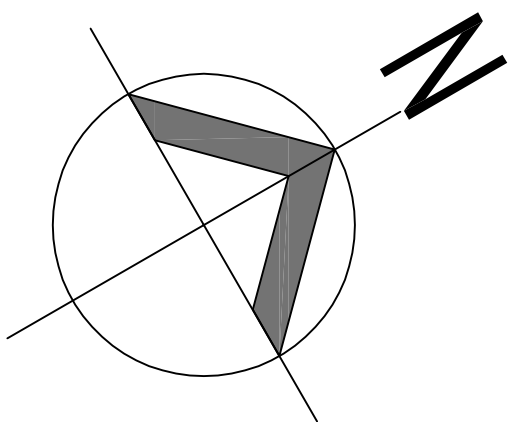


VARIATIONS / WYSYGINGS		
DATE DATUM	No Nr	VARIATION WYSYGING
.	.	.

SYMBOLS LIST

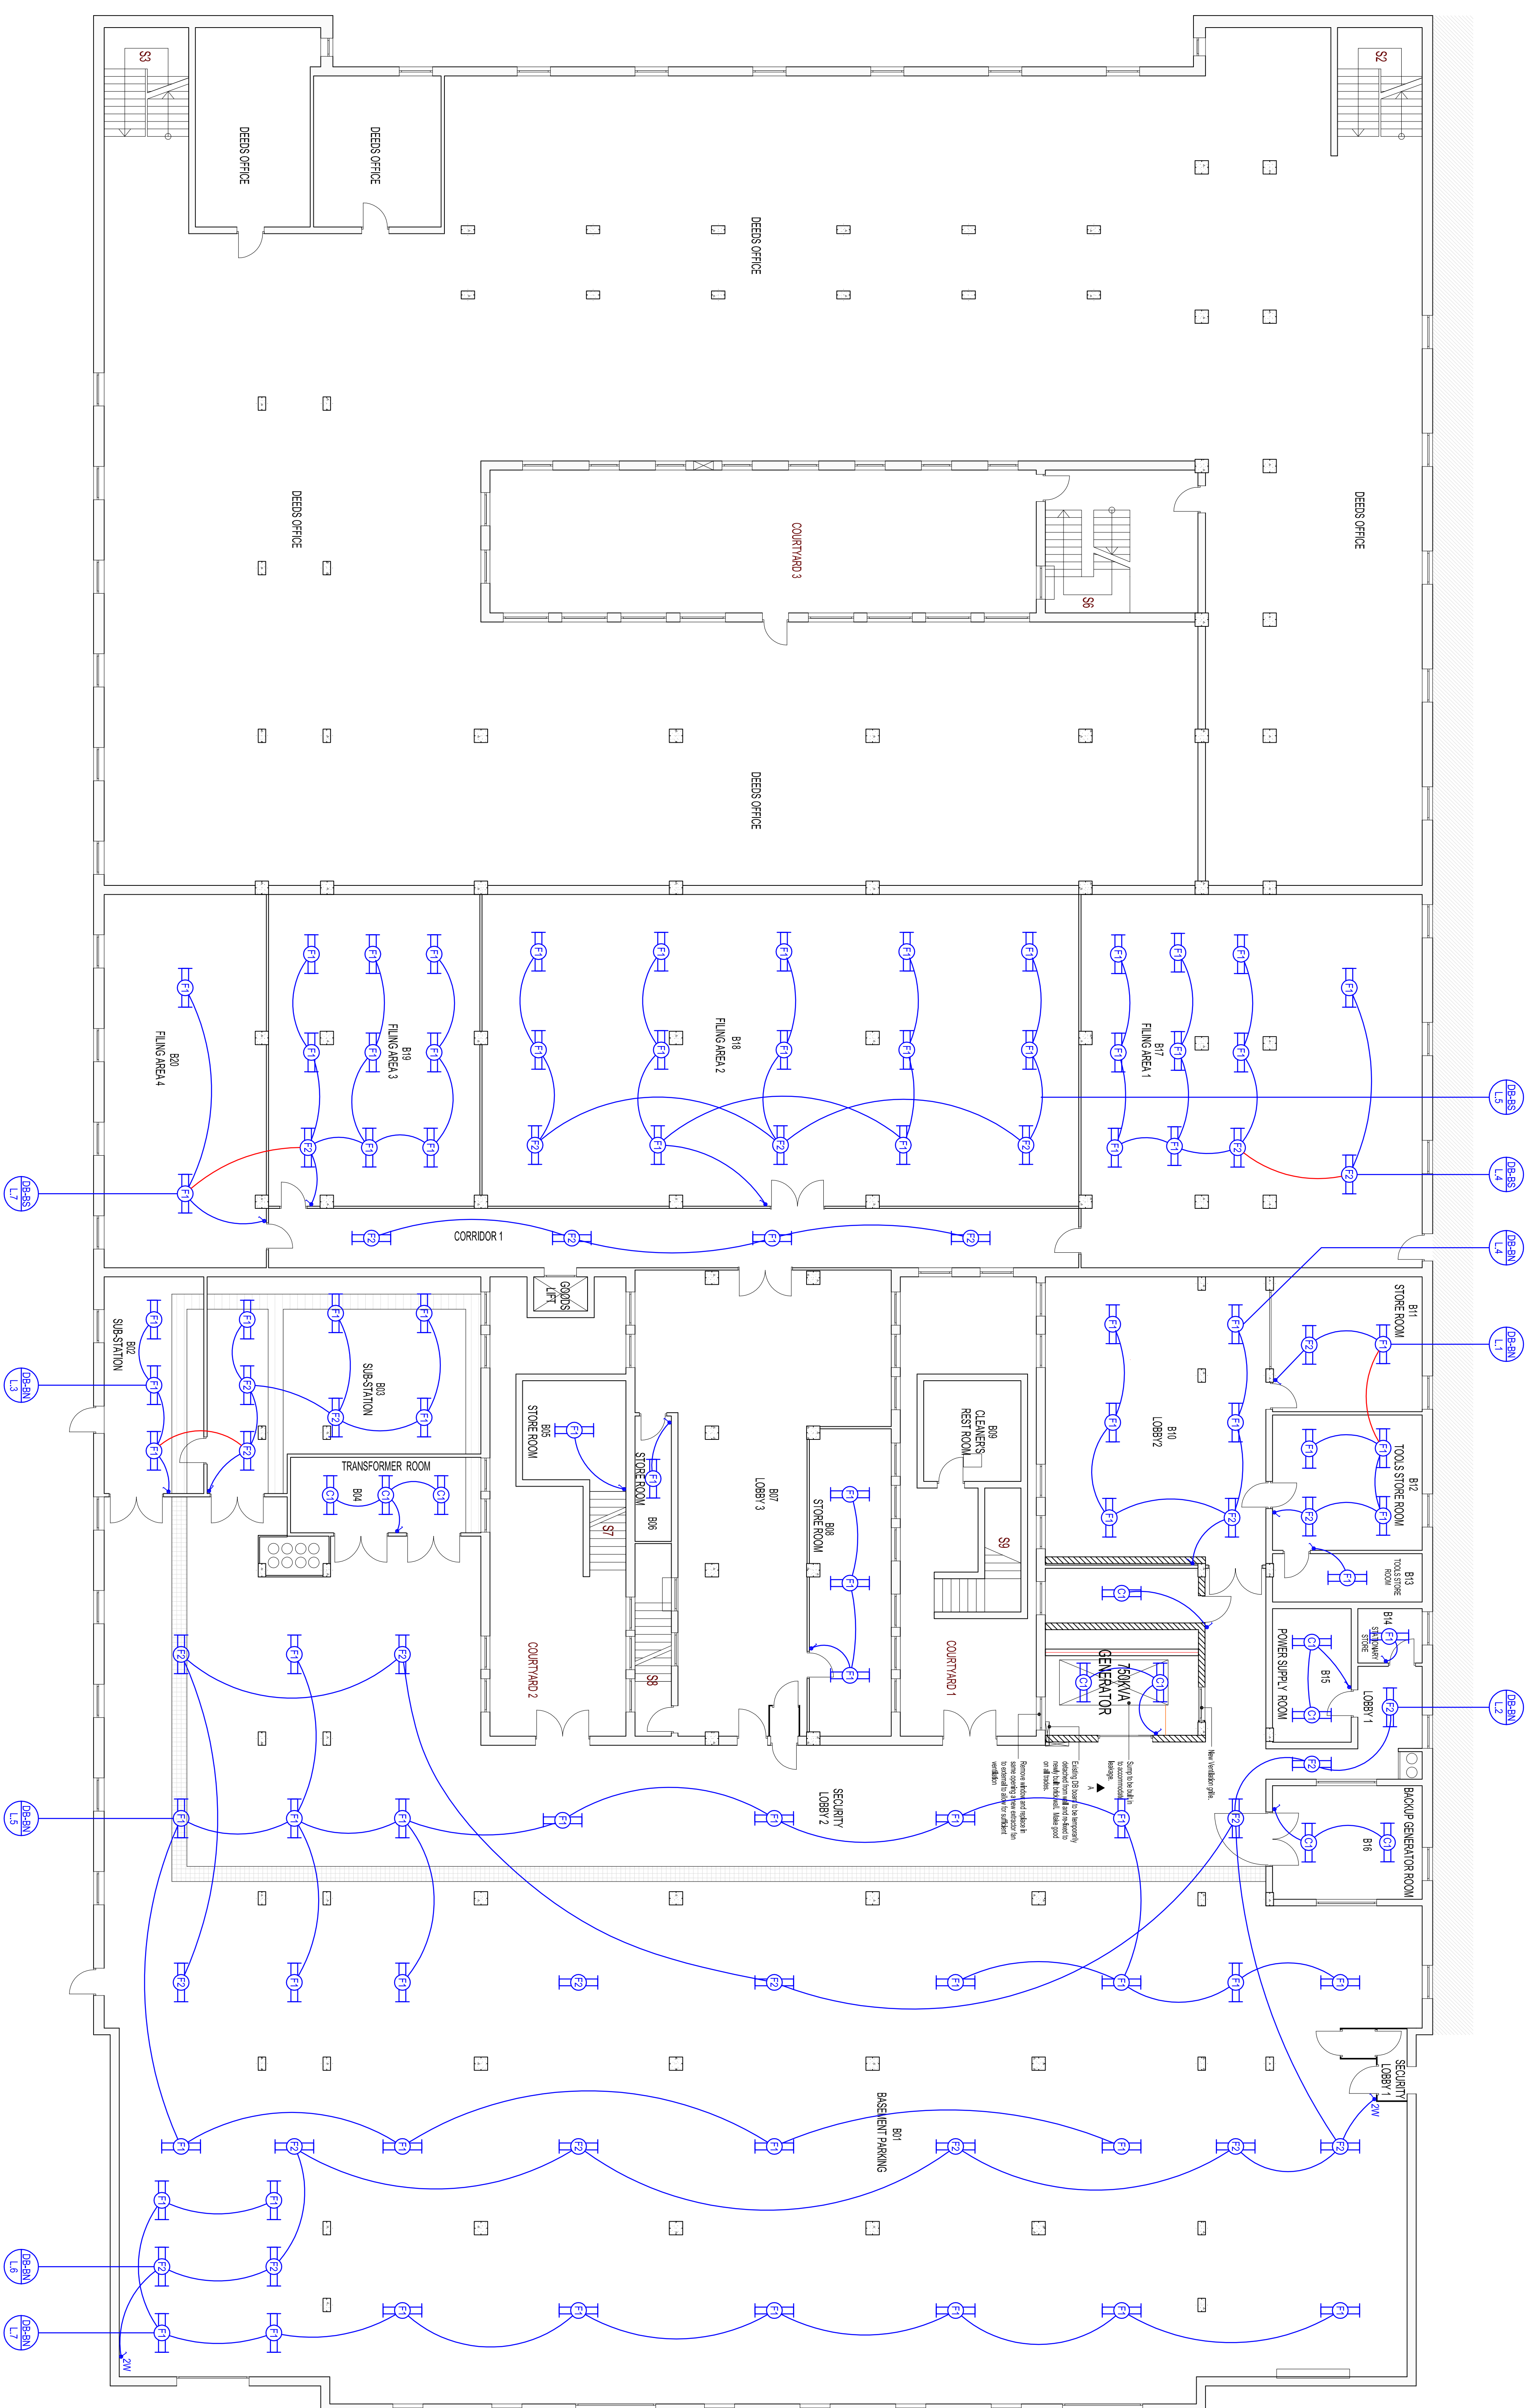

BASEMENT WORKS PLAN

CLIENT		KLIENT	
PROJECT	BOEUMFONTEIN CENTRAL GOVERNMENT BUILDING REFURBISHMENT PROJECT	PROEKT	
DRY REGISTRATION	TEKNOLOGIE-ONTWIKKELING		
ELECTRICAL INSTALLATION	BASEMENT LIGHTING LAYOUT		

SCALE:	DATE:
NOT TO SCALE	FEBRUARY 2014
DRAWING NO:	REVISION:
B03.BFN.000091/E02	0