


FED FROM THE MUNICIPAL/ESKOM SUPPLY MAIN DB

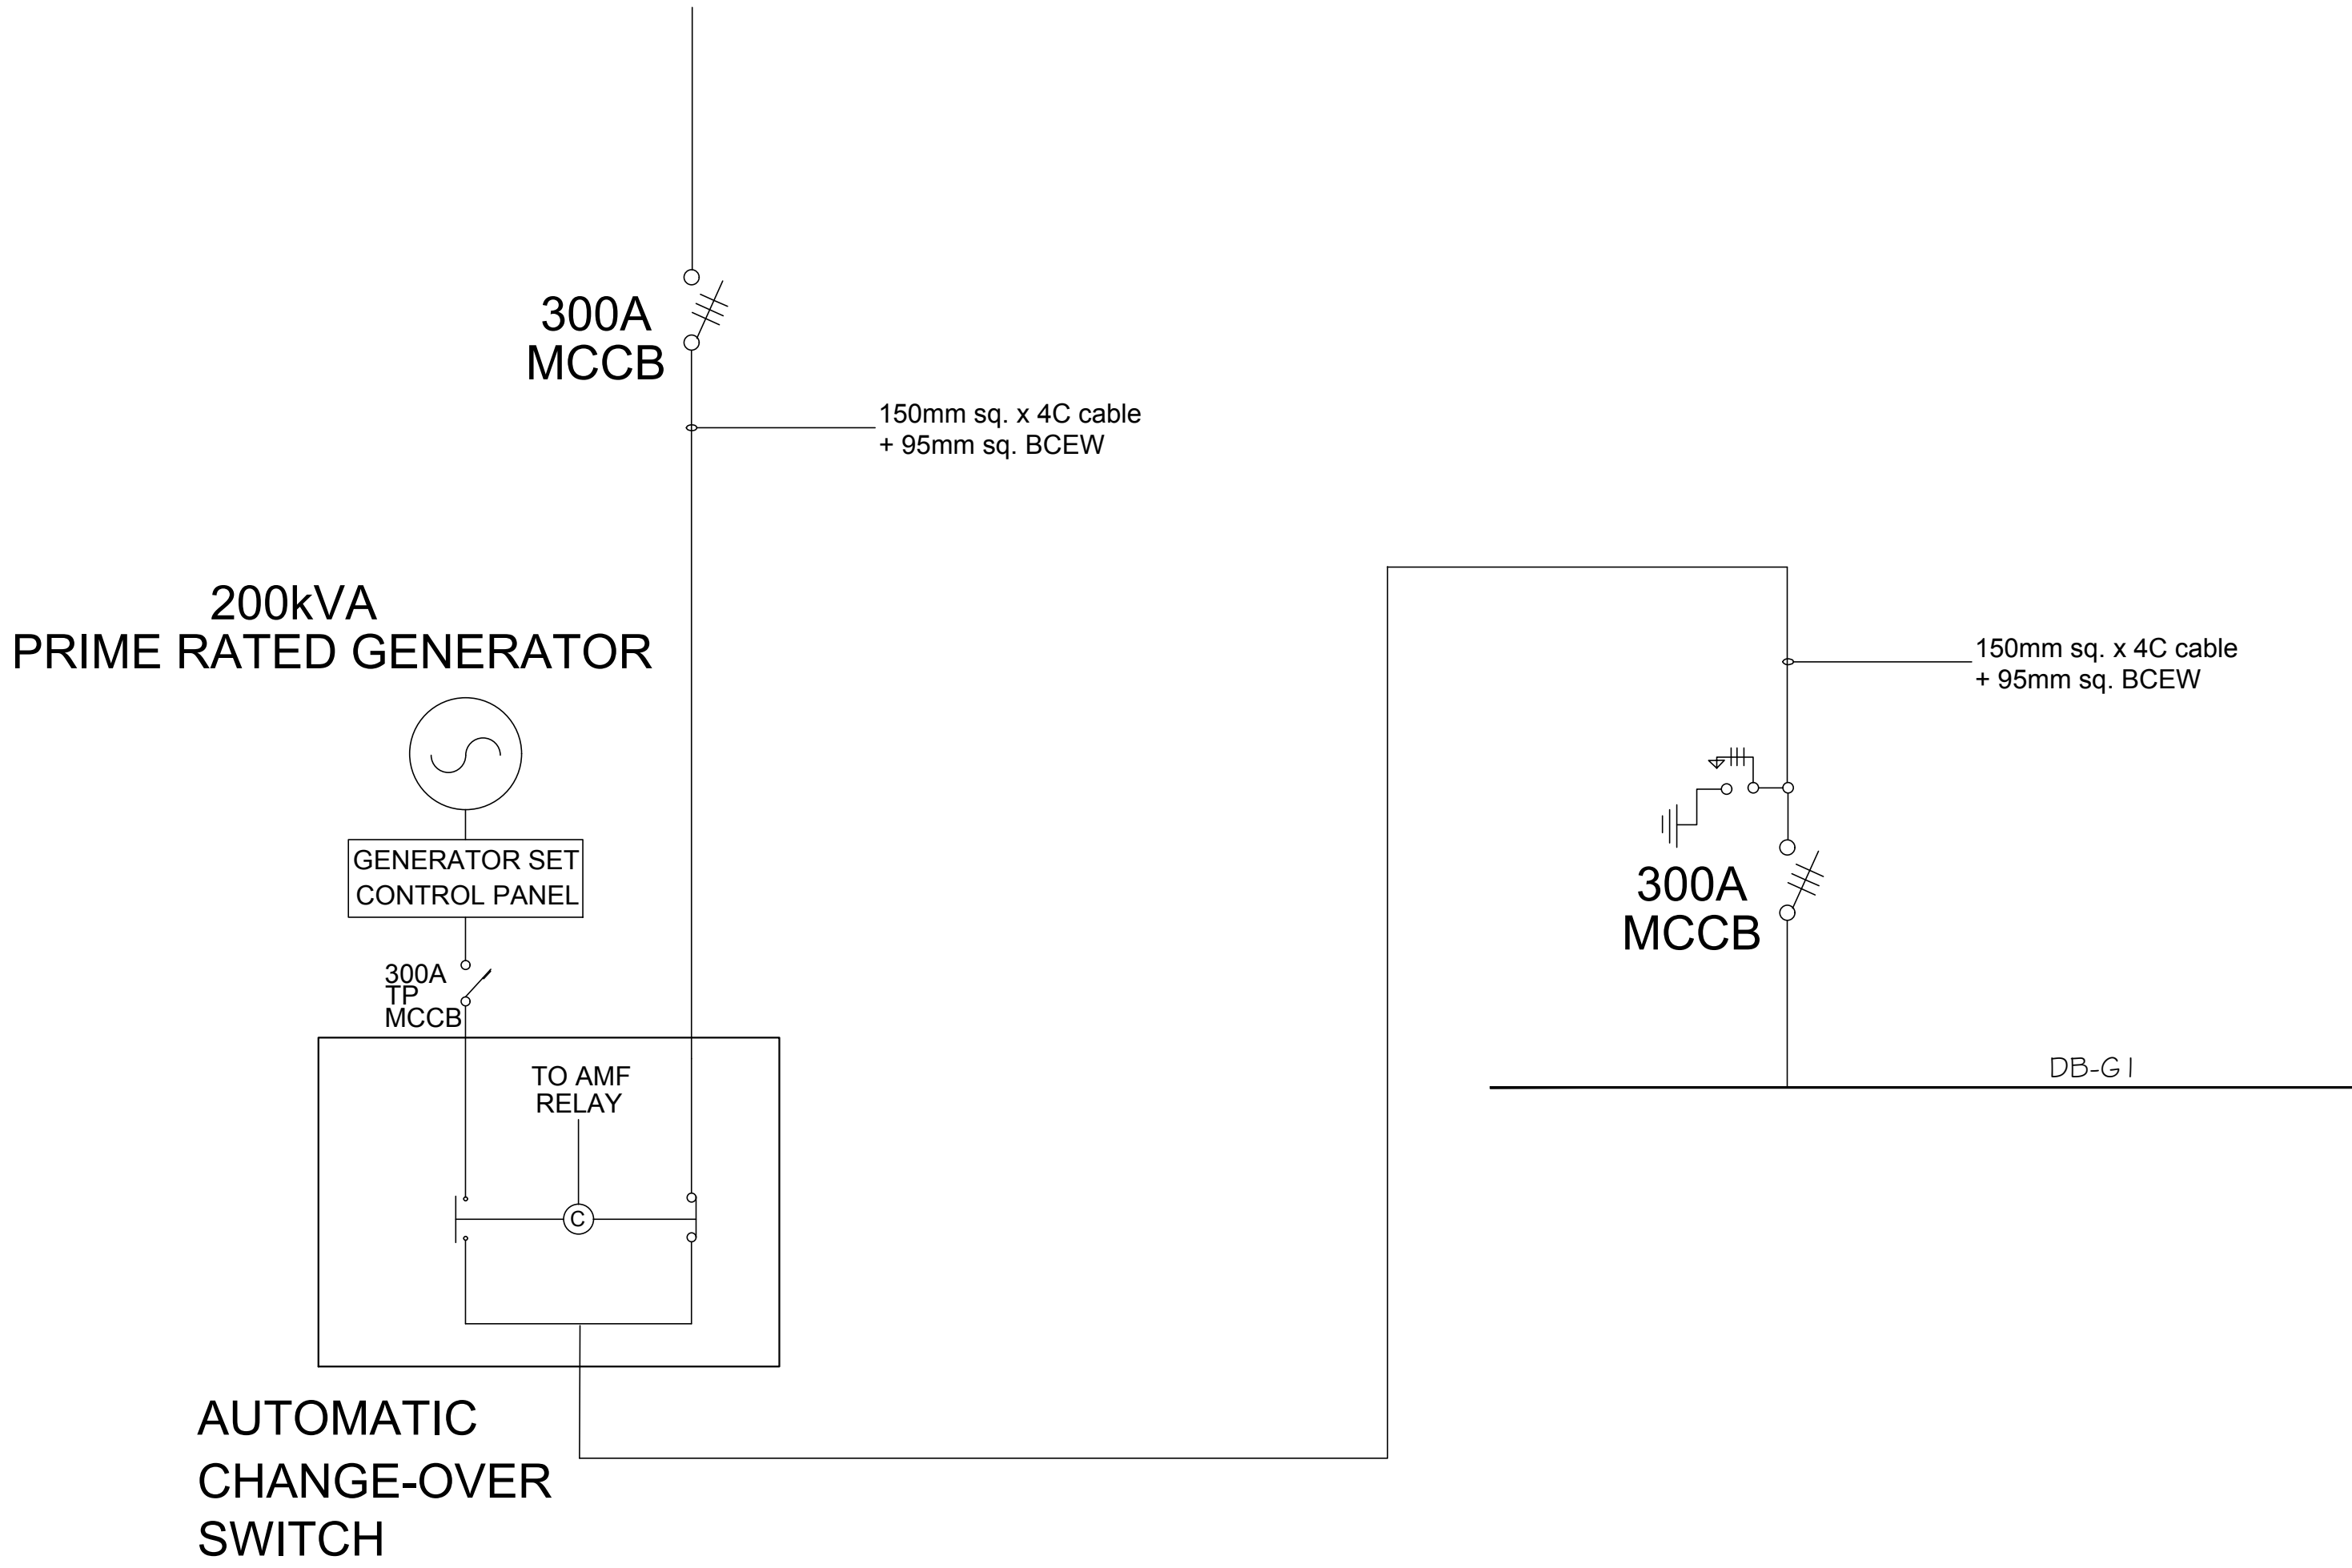

SCHEMATIC SINGLE LINE DIAGRAM FOR NEW 200kVA GENERATOR AT SARS GIYANI OFFICE

TENDER DRAWING

COPYRIGHT E-SQUARE

THIS DRAWING IS THE PROPERTY OF E-SQUARE AND SHALL NOT BE COPIED, PHOTOGRAPHED OR REPRODUCED IN ANY MANNER WHATSOEVER WITHOUT PRIOR WRITTEN PERMISSION OF E-SQUARE. NOR SHALL THE CONCEPTS CONTAINED WITHIN BE USED FOR ANY PURPOSES OTHER THAN THAT AUTHORISED UNDER CONTRACTUAL ARRANGEMENTS WITH E-SQUARE.

GENERAL NOTES

NOTE:

- THIS DRAWING IS TO BE READ IN CONJUNCTION WITH THE ARCHITECTS AND OTHER ENGINEERS DRAWINGS. ANY DISCREPANCIES TO BE BROUGHT TO THE IMMEDIATE ATTENTION OF THE ENGINEER PRIOR TO IMPLEMENTATION OF ANY WORK.


REVISIONS	21/02/2017		
REV. No.	DATE	DESCRIPTION	REV. BY.
0	18/06/2015	ISSUED FOR TENDER	IM
1	21/02/2017	GENERATOR RATING CORRECTION	R.M

CHECKED BY CONSULTANT

NAME


SIGNATUREDATE

CLIENT



SOUTH AFRICAN REVENUE SERVICES

CONSULTANT



e-Square
ENGINEERING

P.O.BOX 2682
NORTH RIDING
2162

Tel +27 (0)11 875 9907
Fax +27 (0)11 875 9906
Email: info@esquareeng.com

DISCIPLINE

ELECTRICAL

JOB TITLE

PROPOSED GENERATOR INSTALLATION

DRAWING TITLE

SINGLE LINE DIAGRAM FOR GENERATOR CONNECTION

ADDRESS/ SITE

SARS, LIMPOPO - GIYANI

DRAWING SCALE		DATE	
AS SHOWN		18-06-2015	
DRAWN BY:	DESIGNED BY:	CHECKED BY:	APPROVED BY:
JM	IM	IM	IM
REVISION No.			1
Client Project No.			-
Drawing No.			13153/4-001