





 









 

 

 


 
 


 

 


FIRE SERVICES DESIGN SUMMARY SCHEDULE				
1 OCCUPANCY INFORMATION				
1.1 FLOOR AREA:	1125	m²		OCCUPIED
1.2 OCCUPANCY CLASS:	G1			OFFICE
1.3 POPULATION:	1/ SEAT		153	NUMBER OF PEOPLE
1.4 ROUTES OF ESCAPE required:	1-off 876mm & 1-off 1160mm wide			
2 FIRE PROTECTION EQUIPMENT				
2.1 FIRE HYDRANT:	1/ 1000	m² = 1	REQUIRED, 90 METERS APART	
2.2 FIRE HOSE REEL:	1/ 500	m² = 2	REQUIRED, WITH 30 METER LONG HOSES	
2.3 EXTINGUISHERS:	1/ 200	m² = 6	REQUIRED, 4.5 KG DCP TYPE	
2.4 SPRINKLER PROTECTIONS:	NO	NOT REQUIRED		
3 RELATED SERVICES				
3.1 FIRE DETECTION:	YES	THROUGHOUT THE BUILDING IN ACCORDANCE WITH SANS 10139:2012 (Category L1)		
3.2 SMOKE VENTILATION:	NO	COMPARTMENTALISED		








- SCOPE OF WORKS CLARIFICATION**
- A. FIRE CONTRACTOR
- SERVICE AND RE-USE EXISTING 2-OFF FIRE HOSE REELS.
 - SUPPLY & INSTALL NEW FIRE FIGHTING EQUIPMENT AS INDICATED ON PLAN.
 - SUPPLY & INSTALL NEW FIRE SIGNAGE AS INDICATED ON PLAN.
 - NEW EVACUATION PLANS & PROCEDURES.
- B. ELECTRICAL CONTRACTOR
- SUPPLY AND INSTALL EMERGENCY LIGHTING THROUGHOUT THE SPACE AS SHOWN ON PLAN, c/w BATTERY BACKUP.
- C. BUILDER.
- SUPPLY AND INSTALL PANIC BARS c/w WHITE ON GREEN "PUSH BAR TO OPEN" SIGN
 - PROVIDING PENETRATIONS THROUGH CEILINGS AND WALLS AND MAKING GOOD THEREOF.
 - FIXING OF EXTINGUISHER BACKING BOARDS TO WALLS SUPPLIED BY FIRE CONTRACTOR.
 - SUPPLY & INSTALL NEW FIRE DOORS c/w 25mm STEEL FRAME AND DOOR CLOSER.
 - FIRE SEALING OF PENETRATIONS THROUGH FIRE WALLS.

CLOUDED INDICATES EXISTING EQUIPMENT

(NEW) - FIRE SIGNS & EQUIPMENT COUNT														
SYMBOL														
REFERENCE	E1	E2	E3	E6	F13	F16	F19	F4	F5	F6	F45	F31	FHR	EXT
QUANTITY	3	3	1	1	3	-	-	1	3	2	1	1	1	4

(EXISTING) - FIRE SIGNS & EQUIPMENT COUNT														
SYMBOL														
REFERENCE	E1	E2	E3	E6	F13	F16	F19	F4	F5	F6	F45	F31	FHR	EXT
QUANTITY	2	1	1	1	3	1	1	1	2	2	1	2	1	5

FIRE DOOR SCHEDULE									
DOOR TAG	SWING	FIRE RATING	DOOR SIZE	DOOR SIZE	OPEN	CLOSED	PANIC BAR	DOOR CLOSER	HOLD OPEN
FD_1	ONE WAY	60 minute	WIDTH (mm)	HEIGHT (mm)	N/A	YES	NO	YES	NO

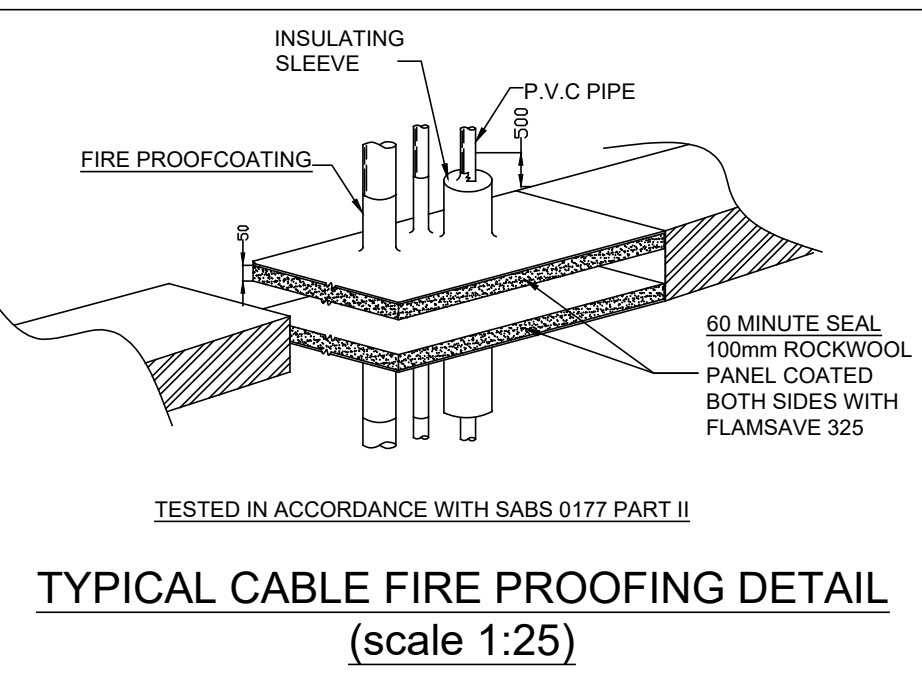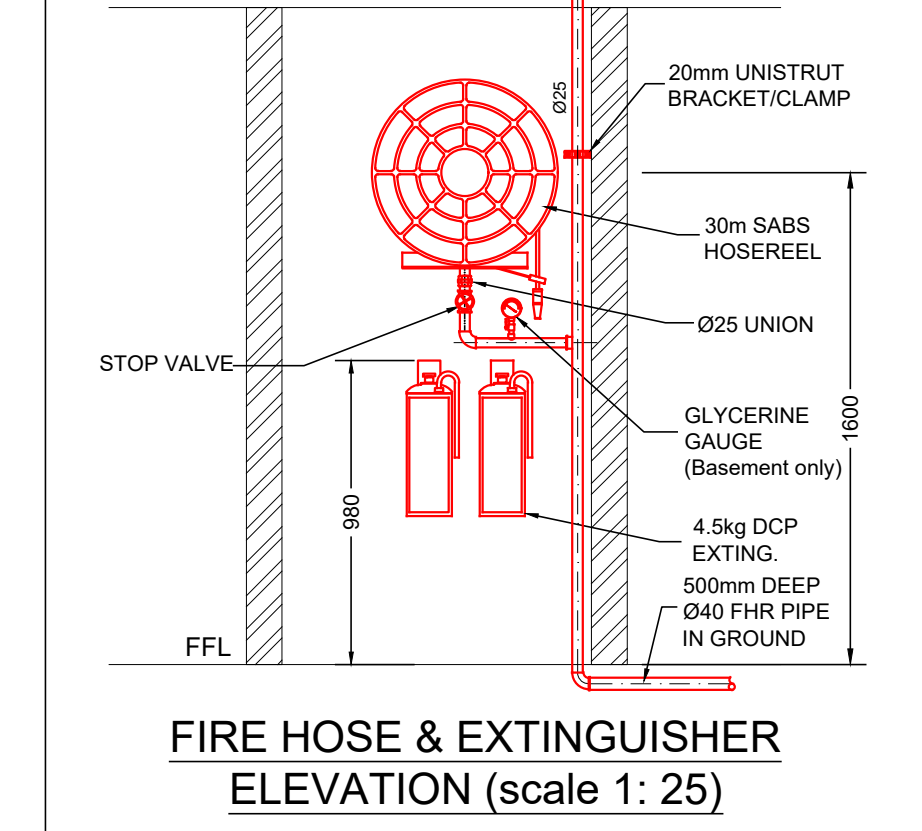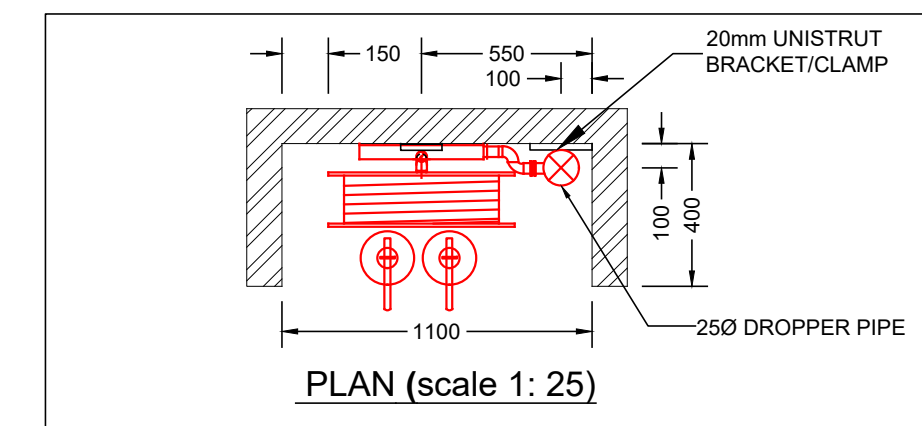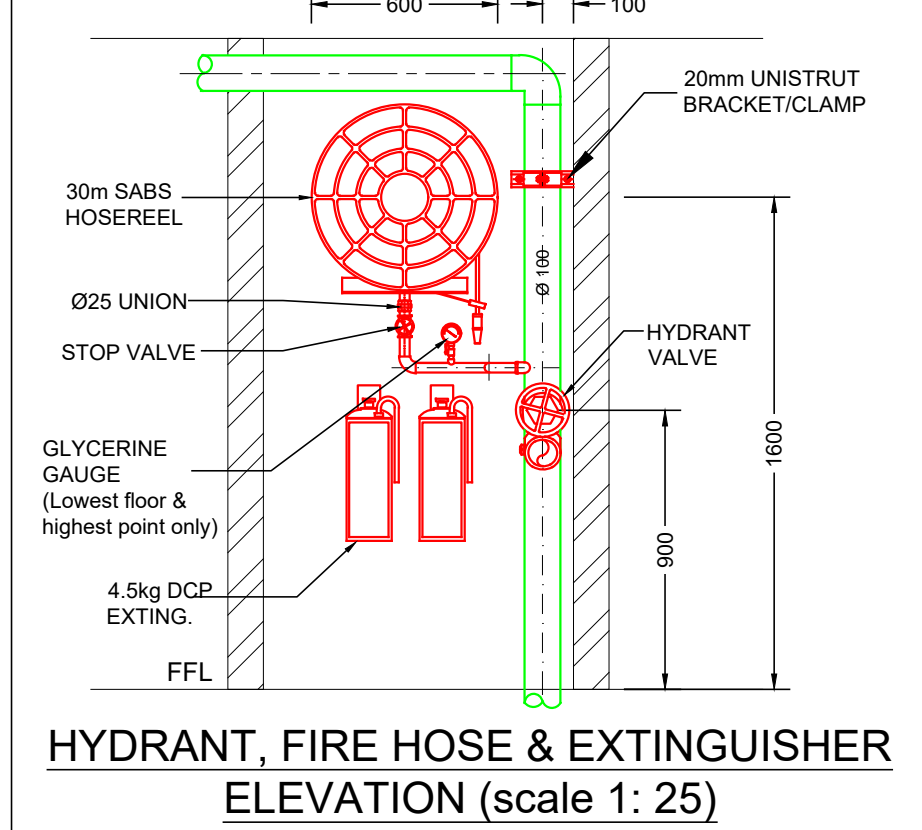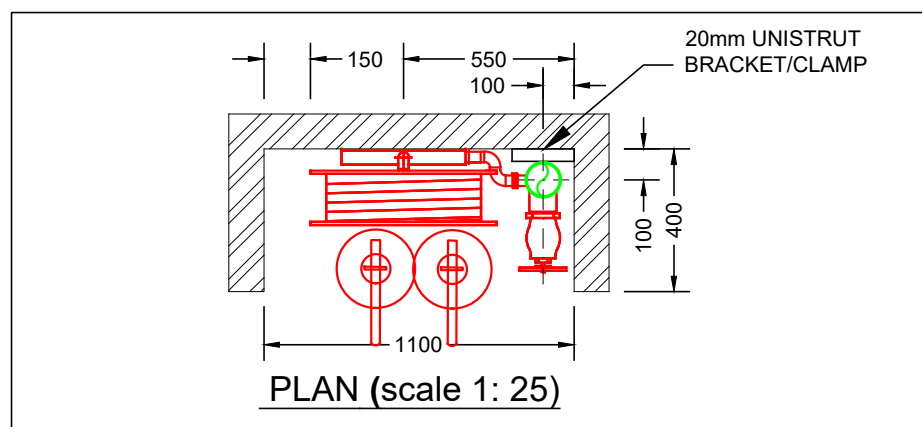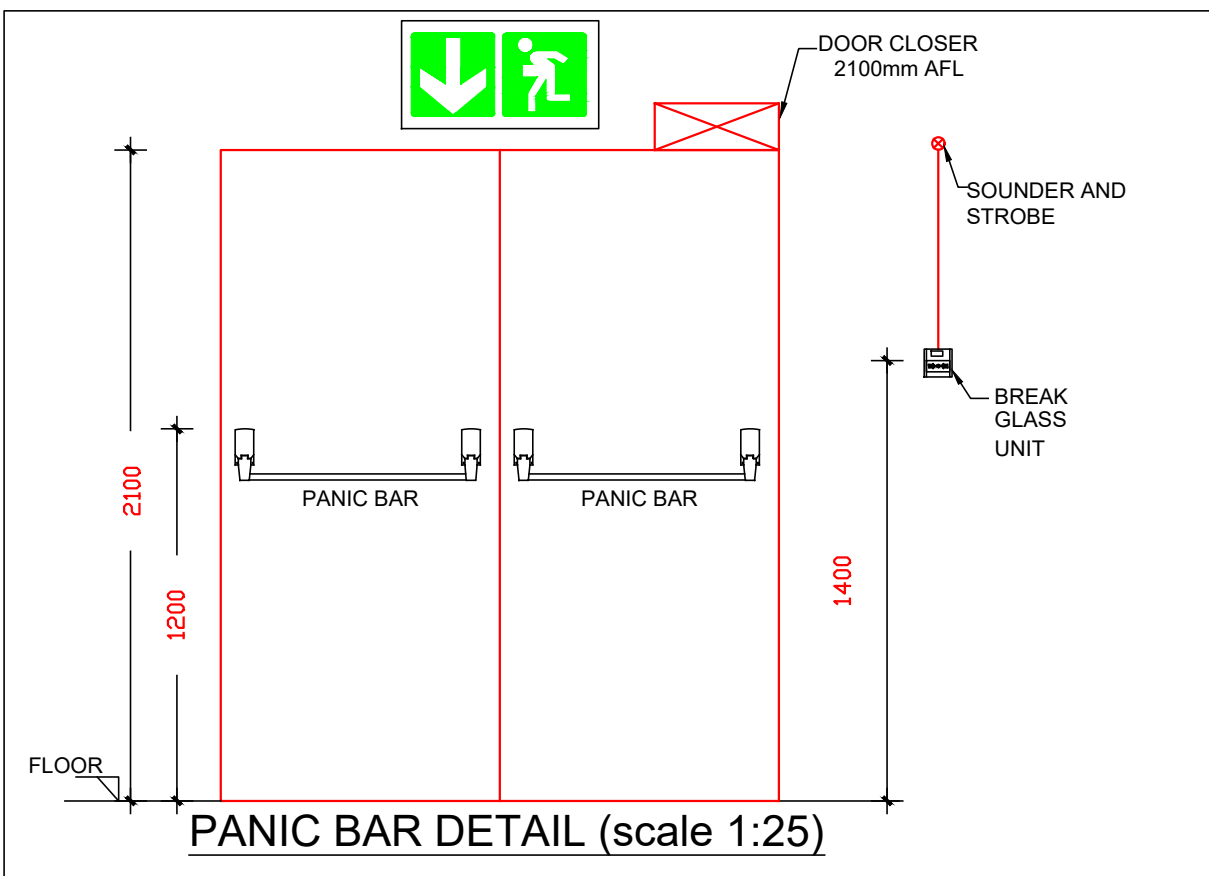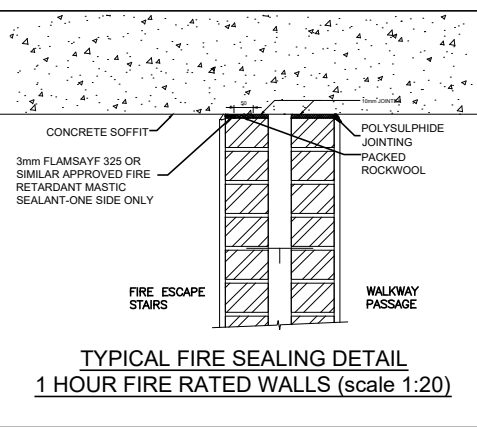

FIRE INSTALLATION NOTES

PORTABLE FIRE EXTINGUISHERS
FIRE EXTINGUISHERS SHALL BE 4.5kg AND 9kg DRY CHEMICAL POWDER TYPE AND SHALL COMPLY WITH SABS 810.
ALL FIRE EXTINGUISHERS SHALL BE MOUNTED ON WOODEN BACKING BOARDS.

FIRE HOSE REELS
FIRE HOSE REELS SHALL CONFORM TO SABS 543.
ALL FIRE HOSE REELS SHALL BE COMPLETE WITH 30 METERS OF HOSE AND SHALL HAVE A MINIMUM FLOW RATE OF 0.5 l/s AT 300 kPa.

FIRE HYDRANTS
FIRE HYDRANTS SHALL COMPLY WITH SABS 543 AND HAVE A MINIMUM FLOW RATE OF 20 l/s AT 300 kPa.

PIPING
NO PIPEWORK TO BE EMBEDDED IN SCREED OR CONCRETE FLOORS.
ALL PIPEWORK SHALL CONFORM TO SABS 62 (STEEL, MEDIUM).

THE DISTANCE BETWEEN PIPE SUPPORT BRACKETS FOR THE HORIZONTAL & VERTICAL PIPEWORK, SHALL NOT EXCEED THE FOLLOWING:
NOMINAL DIAMETER MAXIMUM SPACING
< 65 MM 4M
> 65MM <100MM

PIPING SHALL BE PROPERLY CLEANED OFF SITE, FROM RUST & LOOSE MILL SCALE WITH A HARD WIRE, & DECREASED PRIOR TO APPLICATION OF A RED OXIDE PRIMER.FINAL COATS OF PAINT TO BE 2 OFF SIGNAL RED, HIGH GLOSS ENAMEL TO SABS 630.
ALL BRACKETS, SUPPORTS & FITTINGS TO BE GALVANIZED.
ALL SCREWED JOINTS TO COMPLY WITH BS 21 OR SIMILAR.
SEALINGS OF JOINTS WILL BE WITH HEMP, STOGG OR PTFE TAPE.
HYDRAULIC PRESSURE TESTING SHALL BE DONE TO 15 BAR FOR A PERIOD OF 24 HOURS.

SYMBOLIC SAFETY SIGNAGE
SYMBOLIC SAFETY SIGNAGE SHALL COMPLY WITH SABS 1186 PART V AND SHALL BE OF THE PHOTOLUMINESCENT TYPE.
SIGNAGE SHALL BE INSTALLED SUCH AS TO CLEARLY INDICATE THE POSITIONS OF ALL FIRE EQUIPMENT AND ESCAPE ROUTES.
EACH FLOOR LEVEL SHALL BE NUMBERED IN THE ESCAPE STAIRS.
SIGNAGE ON DRAWING IS AN INDICATION OF SIGNAGE REQUIRED.
FINAL SIGNAGE TO BE DETERMINED ON SITE.
ADDITIONAL SIGNAGE TO BE ADDED SHOULD IT BE REQUESTED BY THE LOCAL AUTHORITIES.
FINAL FIRE SIGNAGE IS TO BE DETERMINED ON SITE WITH THE COUNCIL'S FIRE OFFICER.

FIRE DOORS
FIRE DOORS OF THE RATING AND WIDTH AS INDICATED ON THE DRAWINGS, SHALL BE INSTALLED AND SHALL COMPLY WITH SANS 1253.
ALL FIRE DOORS TO BE FITTED WITH SELF CLOSING MECHANISMS.

FIRE ALARM / DETECTION
FIRE DETECTION AND ALARM SYSTEM SHALL BE INSTALLED AS INDICATED ON THE DRAWINGS AND IN ACCORDANCE WITH SANS 10139.

ESCAPE DOORS
ALL ESCAPE DOORS SHALL BE COMPLETE WITH FIRE ESCAPE IRONMONGERY.

FIRE ESCAPE ROUTES
FIRE ESCAPE ROUTES, INCLUDING CORRIDORS AND STAIRWAYS SHALL HAVE MINIMUM WIDTH OF 1500mm UNLESS SHOWN OTHERWISE.
ALL ESCAPE ROUTES SHALL HAVE A FIRE RESISTANCE AS INDICATED.
ALL EMERGENCY ROUTES SHALL HAVE A FIRE RESISTANCE AS INDICATED ON THE DRAWINGS.

FIRE SERVICES LEGEND	
	BREAK GLASS UNIT
	FIRE HYDRANT
	DIRECTIONAL ARROW
	60MIN FIRE RATED LIFT LANDING DOOR
	60 MINUTE FIRE RATED WALL
	HOSE REEL
	4.5kg DCP FIRE EXTINGUISHER
	FIRE ESCAPE

FIRE DESIGN CONFIRMATION		
DEEMED TO SATISFY WITH SANS 10400		N/A
RATIONAL ASSESSMENT		YES
RATIONAL DESIGN EQUIVALENT OR SUPERIOR TO SANS 10400		N/A

ISSUE DATE:	2023-08-23	REVISION:	B
X FOR INFORMATION			
FOR APPROVAL			
FOR TENDER			
FOR CONSTRUCTION			
AS-BUILT			

REVISIONS				
No	Date	Description	Rev By	Ckd By
A	02/08/2021	ISSUED FOR INFORMATION	S.M	H.R
B	23/08/2023	ISSUED FOR INFORMATION	S.M	H.R

CONSULTMECH
Mechanical Engineers

09 Plantanus Street
Kuilsvier
7580

Cell: (072) 948 4470
Tel: (021) 903 1407
Email: info@consultmech.co.za

PROJECT: LAHAE LA SARS - BLOCK A

DWG TITLE: BROOKLYN

DWG NUMBER: 21B09-F-501-04

DESIGNED BY: S. MAFUYA

CHECKED BY: H.D ROUX

APPROVED BY: H.D ROUX

SCALE: 1:100 @ A1

ECSA NUMBER: 201070151

REV. B

COPYRIGHT AND RIGHT OF REPRODUCTION OF THIS DRAWING OR ANY PORTION THEREOF IS RESERVED BY THE ENGINEERS

GROUND STOREY - PROPOSED FIRE SERVICES LAYOUT (Scale 1:100)